 
 
 
 
 
 



ELECTRICAL LEGEND			
	DUPLEX RECEPTACLE		SCONCE
	GROUND FAULT INTERRUPTER WATER PROOF		CEILING MOUNTED LIGHT FIXTURE EXHAUST FAN COMBO
	QUADRUPLEX RECEPTACLE		CEILING FAN
			FAN OUTLET
	1/2 SWITCH - DUPLEX RECEPTACLE		SMOKE ALARM CEILING MOUNT
	120 VOLTS		DOORBELL CHIMES
	SPECIAL OUTLET		PHONE OUTLET
	SWITCH		TELEVISION OUTLET
	3 WAY SWITCH		DOOR BELL
	4 WAY SWITCH		OPT GARAGE DOOR OPENER
	SWITCH ON DIMMER		ELECT PANEL
	INCANDESCENT LIGHTING SURFACE MOUNTED		ELECT METER
	INCANDESCENT LIGHTING WALL MOUNTED		THERMOSTAT
	RECESSED LIGHTING - HI-HATS, ETC.		SPEAKER
	VAPOR PROOF		INTERCOM
	FLOOD LIGHTS		2x4 FLUORESCENT LIGHTING
	PULL CHAIN		LIGHT FIXTURE
	FLUORESCENT LIGHTING		MAKE-UP LIGHTING
	MINI- SPOTS		TRACK LIGHTS
	EYEBALL SPOTLIGHT		DISCONNECT
	HEATLAMP		DISPOSAL
	ROUND FLUORESCENT		POWER BUTTON
	DIRECTIONAL SPOTLIGHT		FLOOR OUTLET

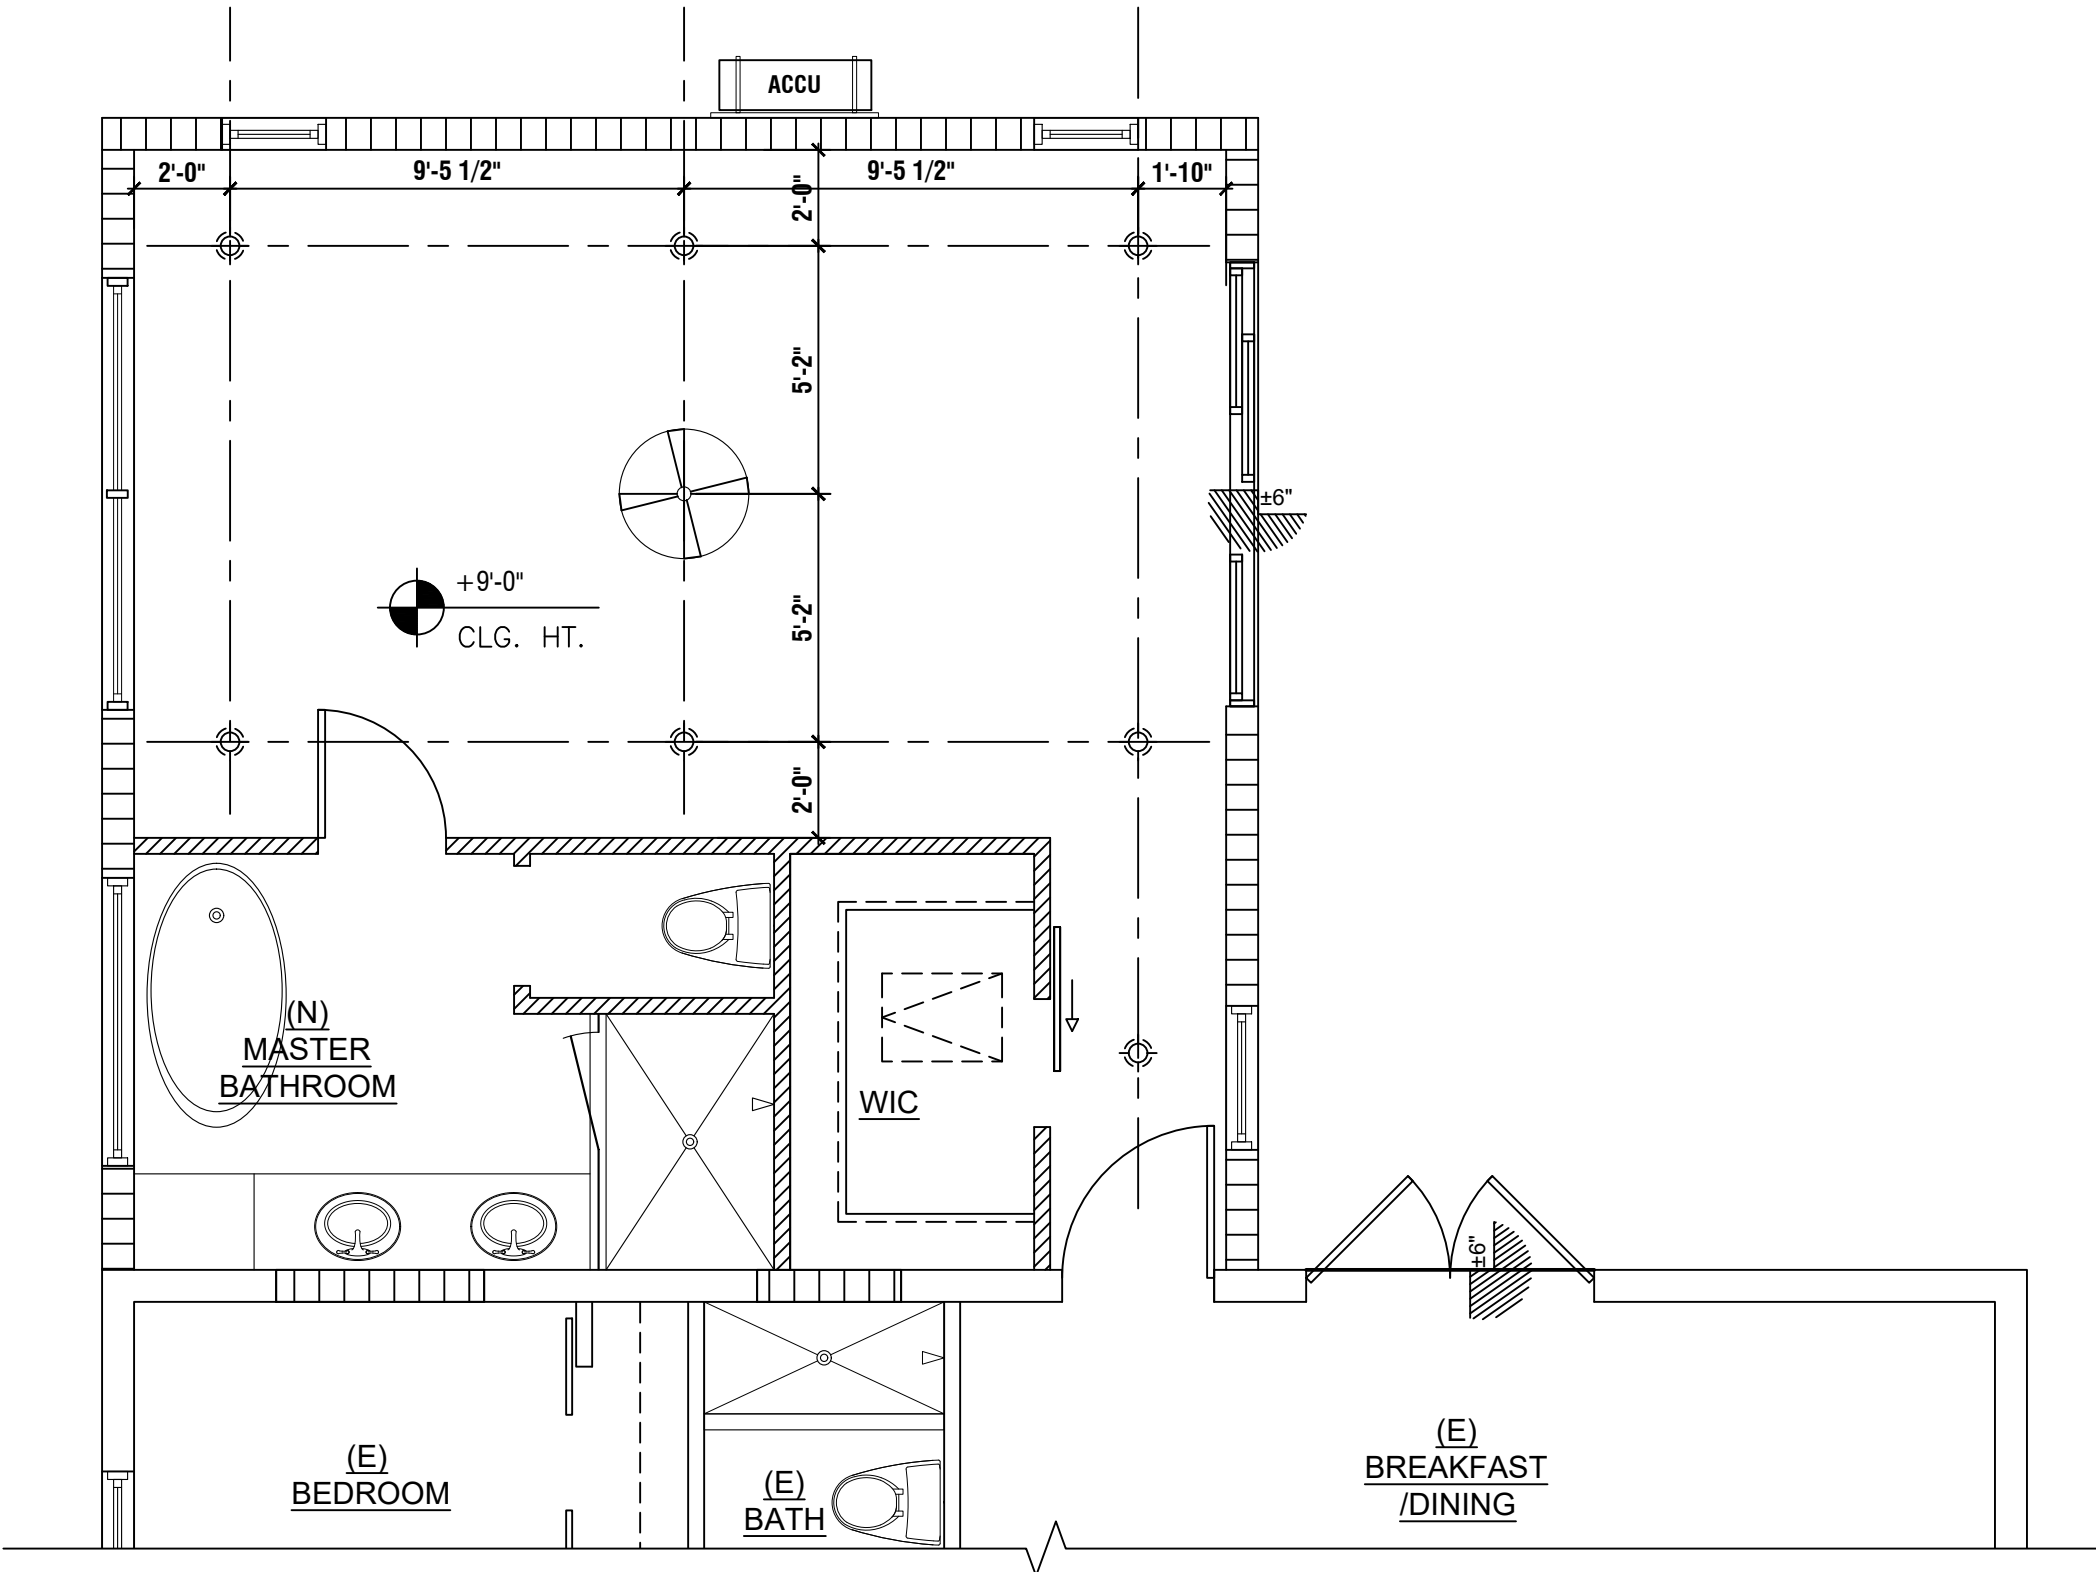

ELECTRICAL REFLECTED CEILING PLAN

SCALE: 1/4" = 1'-0"

DEMETRIOS

CHRISTOPOULOS

ARCHITECT

KINO-PAUL RICHARDS

PROJECT MANAGER

STATE LIC AR072601

434 S. FLORISSA ROAD

DEERFIELD BEACH

FL 33441

954 821 6707

www.demetriosdesign.net

NO.	1	2	3	100
NO.	1	2	3	100

ADDITION TO:

YONIQUE GORDON

RESIDENCE

6620 NW 25TH STREET, SUNRISE FL, 33313

ARCHITECT'S SEAL

COMM. NO.
DATE
5/1/2025

DRAWN BY
KPR
CHECKED BY
DLC
SHEET NUMBER

E-2
OF 14